


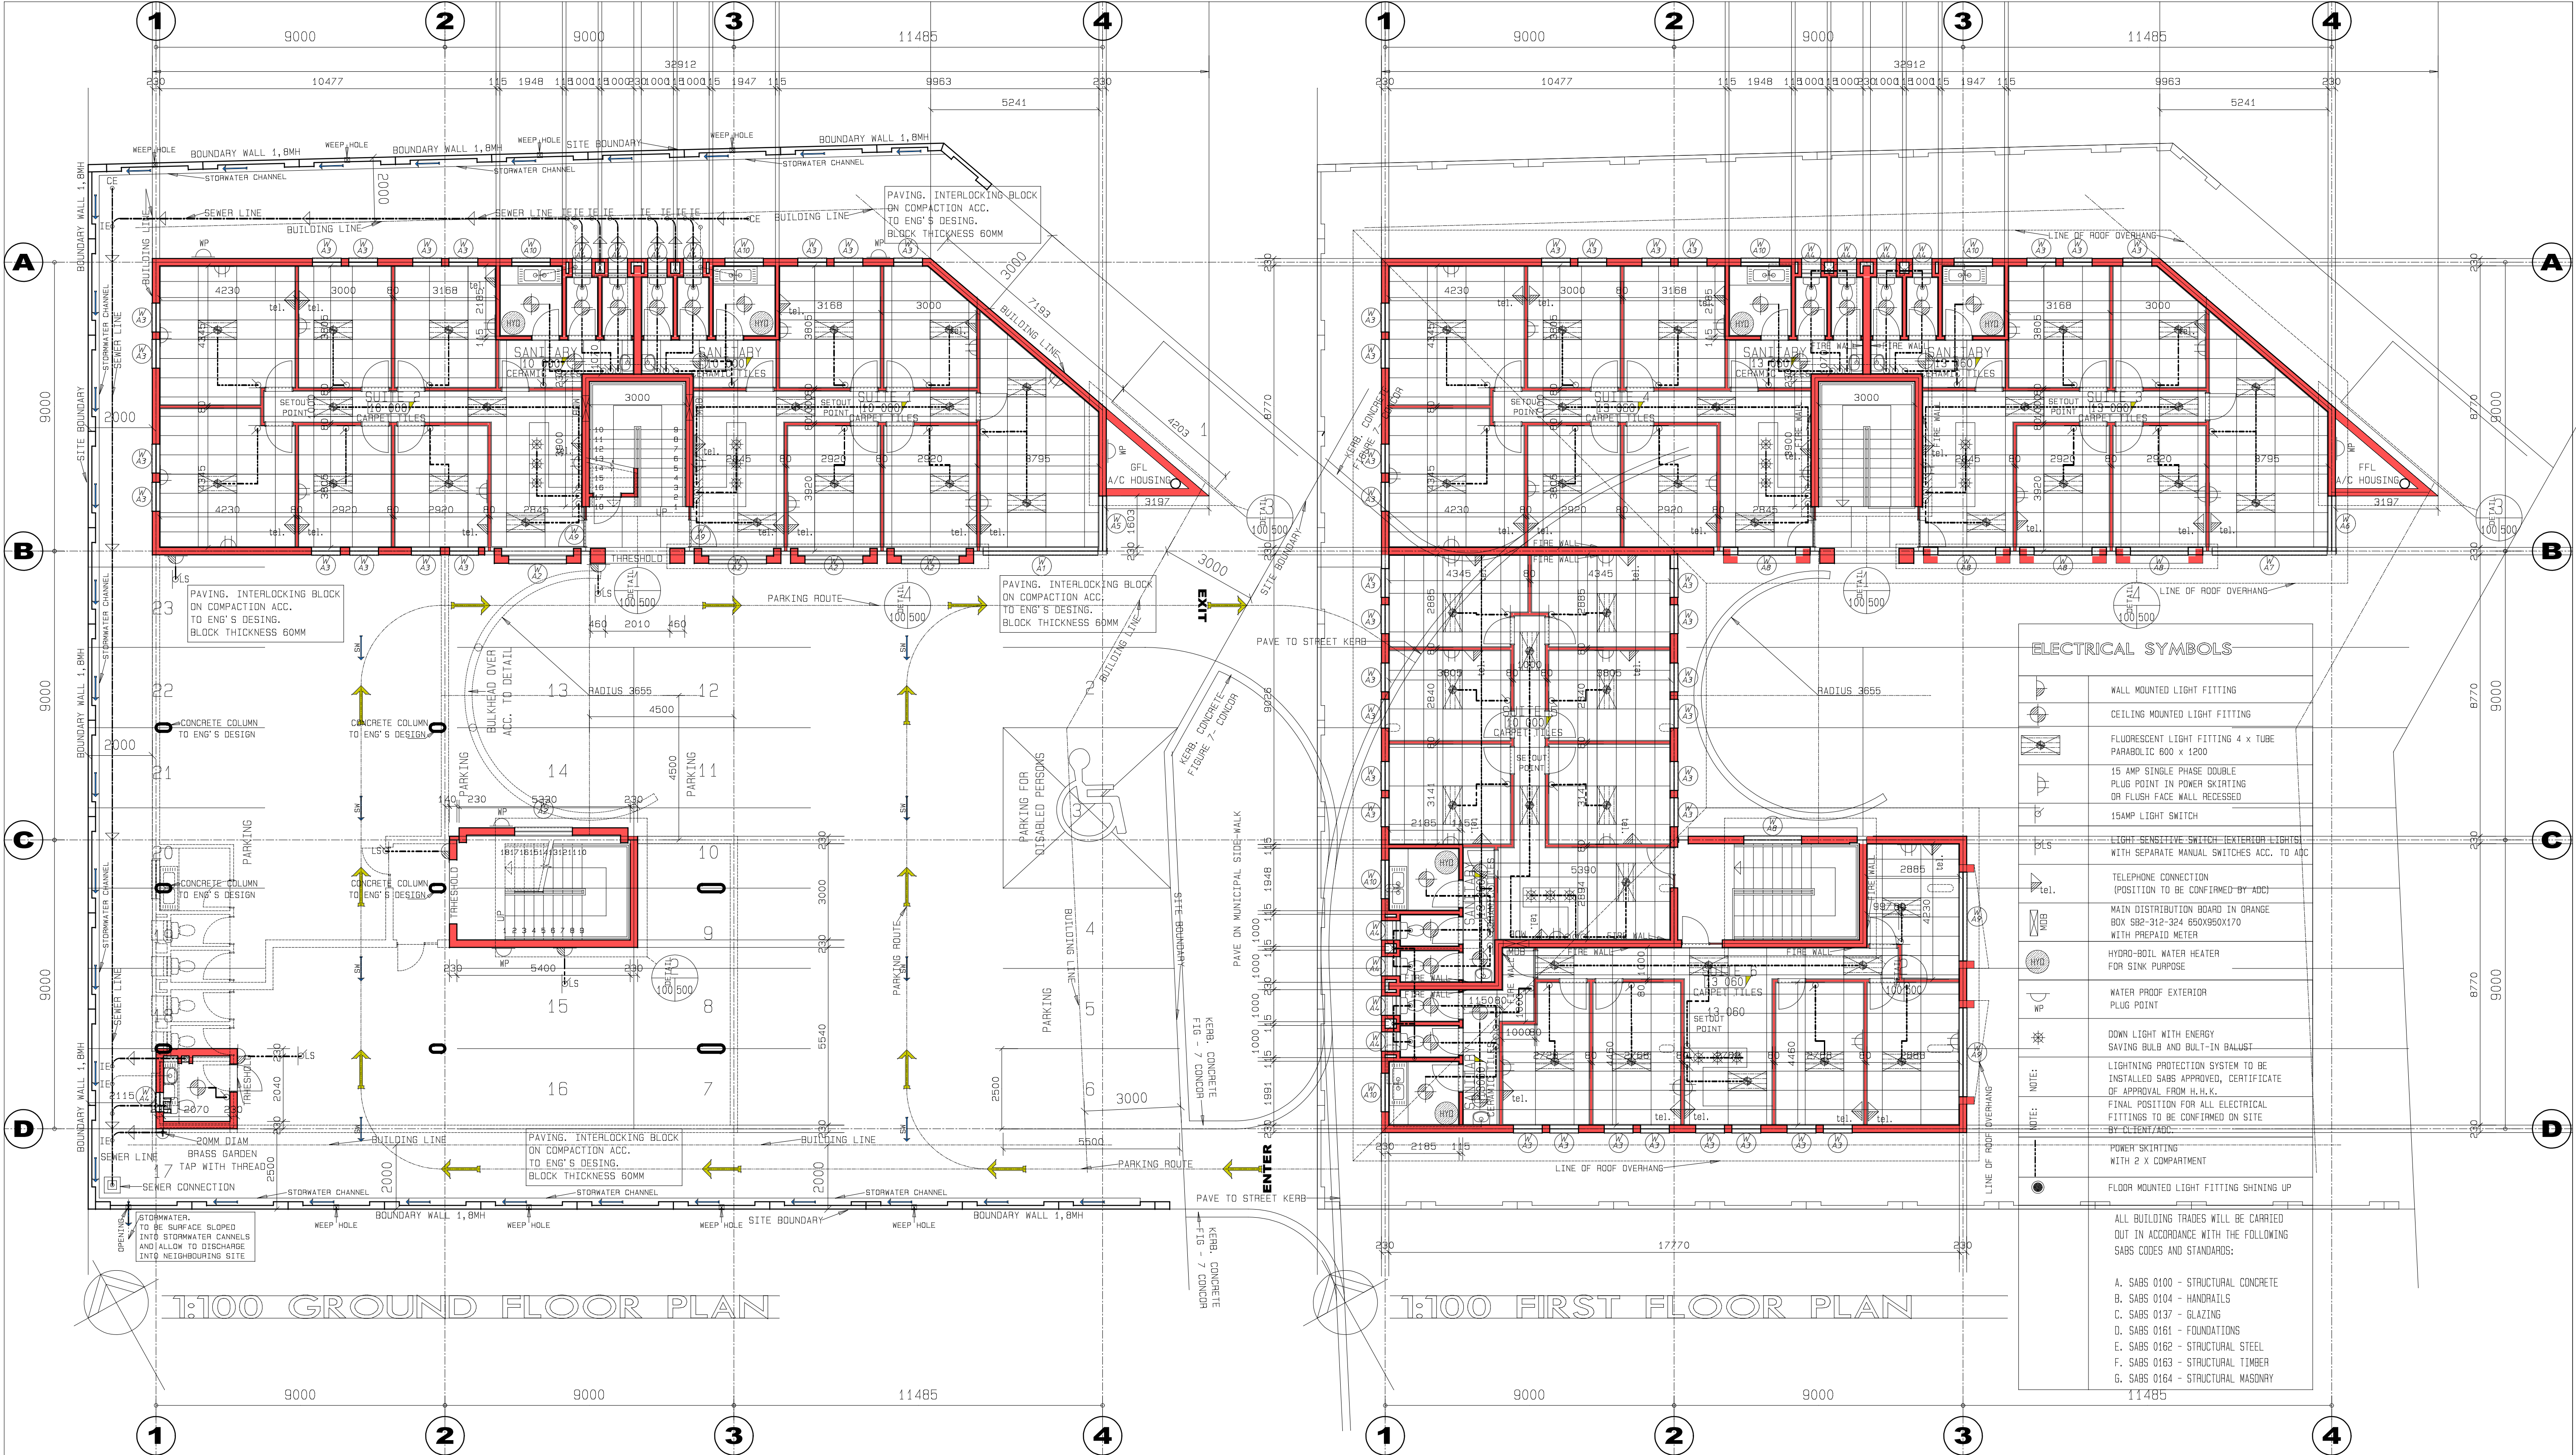

ELECTRICAL SYMBOLS

	WALL MOUNTED LIGHT FITTING
	CEILING MOUNTED LIGHT FITTING
	FLUORESCENT LIGHT FITTING 4 x TUBE PARABOLIC 600 x 1200
	15 AMP SINGLE PHASE DOUBLE PLUG POINT IN POWER SKIRTING OR FLUSH FACE WALL RECESSED
	15AMP LIGHT SWITCH
	LIGHT SENSITIVE SWITCH (EXTERIOR LIGHTS) WITH SEPARATE MANUAL SWITCHES ACC. TO ADC
	TELEPHONE CONNECTION (POSITION TO BE CONFIRMED BY ADC)
	MAIN DISTRIBUTION BOARD IN ORANGE BOX 582-312-324 650x950x170 WITH PREPAID METER
	HYDRO-BOLT WATER HEATER FOR SINK PURPOSE
	WATER PROOF EXTERIOR PLUG POINT
	DOWN LIGHT WITH ENERGY SAVING BULB AND BUILT-IN BALUST
	LIGHTNING PROTECTION SYSTEM TO BE INSTALLED SABS APPROVED, CERTIFICATE OF APPROVAL FROM H.H.K.
	FINAL POSITION FOR ALL ELECTRICAL FITTINGS TO BE CONFIRMED ON SITE BY CLIENT/ADC
	POWER SKIRTING WITH 2 x COMPARTMENT
	FLOOR MOUNTED LIGHT FITTING SHINING UP

ALL BUILDING TRADES WILL BE CARRIED OUT IN ACCORDANCE WITH THE FOLLOWING SABS CODES AND STANDARDS:

- A. SABS 0100 - STRUCTURAL CONCRETE
- B. SABS 0104 - HANDRAILS
- C. SABS 0137 - GLAZING
- D. SABS 0161 - FOUNDATIONS
- E. SABS 0162 - STRUCTURAL STEEL
- F. SABS 0163 - STRUCTURAL TIMBER
- G. SABS 0164 - STRUCTURAL MASONRY

DETAIL SYMBOL			
location sheet detail sheet			
REVISIONS			
No.	DATE	DESCRIPTION	SIGN
1	20-07-2012	FOR APPROVAL DRAWINGS OMIT SIDE ENTRANCE	RIAN

- GENERAL NOTES:
- CONTRACTOR TO VERIFY ALL LEVELS, HEIGHTS & DIMENSIONS ON SITE PRIOR TO COMMENCEMENT OF WORK.
 - LARGE SCALE DRAWINGS ENJOY PREFERENCE OVER SMALL SCALE DRAWINGS.
 - DO NOT SCALE DRAWINGS, DIMENSIONS ONLY TO BE USED.
 - ADC ACCEPTS NO RESPONSIBILITY FOR ANY WORK TO BE ERECTED ON EXISTING FOUNDATIONS.
 - DAMAGE TO UNKNOWN SERVICES.
 - THE CONTRACTOR'S LIABILITY WHEN HE ENCOUNTERS UNKNOWN SERVICES IS TO NOTIFY THE ADC IMMEDIATELY THEREOF AND TO SUSPEND ALL AFFECTED WORK IN THE IMMEDIATE VICINITY UNTIL WRITTEN INSTRUCTION TO PROCEED HAS BEEN GIVEN BY THE ADC.
 - IF ANY PARTICULARS AND MEANING OF THE DESCRIPTION OF ANY ITEM IS NOT CLEAR OR IS AMBIGUOUS, INDISTINCT OR CAUSE CONFUSION AS TO THEIR MEANING OR IF ANY OBVIOUS ERRORS OCCUR ON THE DRAWINGS, THE CONTRACTOR MUST INFORM ADC IMMEDIATELY AND HAVE THE ERROR CORRECTED OR EXPLAINED AS THE CASE MAY BE.
 - CONTRACTOR TO CONFIRM ELECTRICAL LAY-OUT AND LIGHT FITTING TYPES WITH CLIENT PRIOR TO COMMENCEMENT OF ANY BUILDING WORK.
 - COPY RIGHT RESERVED BY ADC.
 - SPECIALIST ROOF CONTRACTOR RESPONSIBLE FOR DESIGN AND SUPPLY OF ROOF CONSTRUCTION.

- SEWER NOTES:
- S1 110mm UPVC STUB SOIL, VENT & CE.
- S2 110mm UPVC SOIL PIPE, FALL 1:40
- S3 50mm UPVC WASTE PIPE TO DISCHARGE INTO DISHED GULLEY
- S4 CONCRETE DISHED GULLEY WITH CAST IRON COVER
- S5 FLOW DIRECTION AND FALL 1:40
- NOTE :
FINAL SEWER DEPTH AND INVERTED LEVEL TO BE DETERMINED ON SITE IN ACCORDANCE WITH SLOPE AND GROUND FORMATION.

ALL BUILDING TRADES WILL BE CARRIED OUT IN ACCORDANCE WITH THE FOLLOWING SABS CODES AND STANDARDS:

A. SABS 0100 - STRUCTURAL CONCRETE
B. SABS 0104 - HANDRAILS
C. SABS 0137 - GLAZING
D. SABS 0161 - FOUNDATIONS
E. SABS 0162 - STRUCTURAL STEEL
F. SABS 0163 - STRUCTURAL TIMBER
G. SABS 0164 - STRUCTURAL MASONRY

CLIENT'S SIGNATURE OF APPROVAL
NAME:.....
SIGNATURE:.....
DATE:.....

SDP
MUNDOC

ARCHITECTURAL DESIGN & DEVELOPMENT CONSULTANTS
P.O. BOX 1018
POLOKWANE
0699
TEL: 015 - 297 4572
FAX: 015 - 297 6759
E-MAIL: adc2000@web.co.za

DRAWING TITLE **APPROVAL DOCUMENTATION**
1:200 SITE PLAN

ENQUIRY - R. DU PREEZ
MOBILE - 082 2586 780

PROJECT TITLE			
PROPOSED BUILDING ON ERF 6853 ISMINI OFFICE PARK POLOKWANE			
DESIGN RIAN DU PREEZ PROJECT ARCHT. SACAP, LIA (S10384) MEMBER: LIMPPO INSTITUTE FOR ARCHITECTURE No. 0048 DRAWING DIVISION ANDRIES PIETERSE			
PROJECT No	DWG No	REV	
409	100	0	
SCALE 1:200	DATE 1 Jun 2015	DRAWN R.D.P. A.P.	CHECKED R.D.P.