


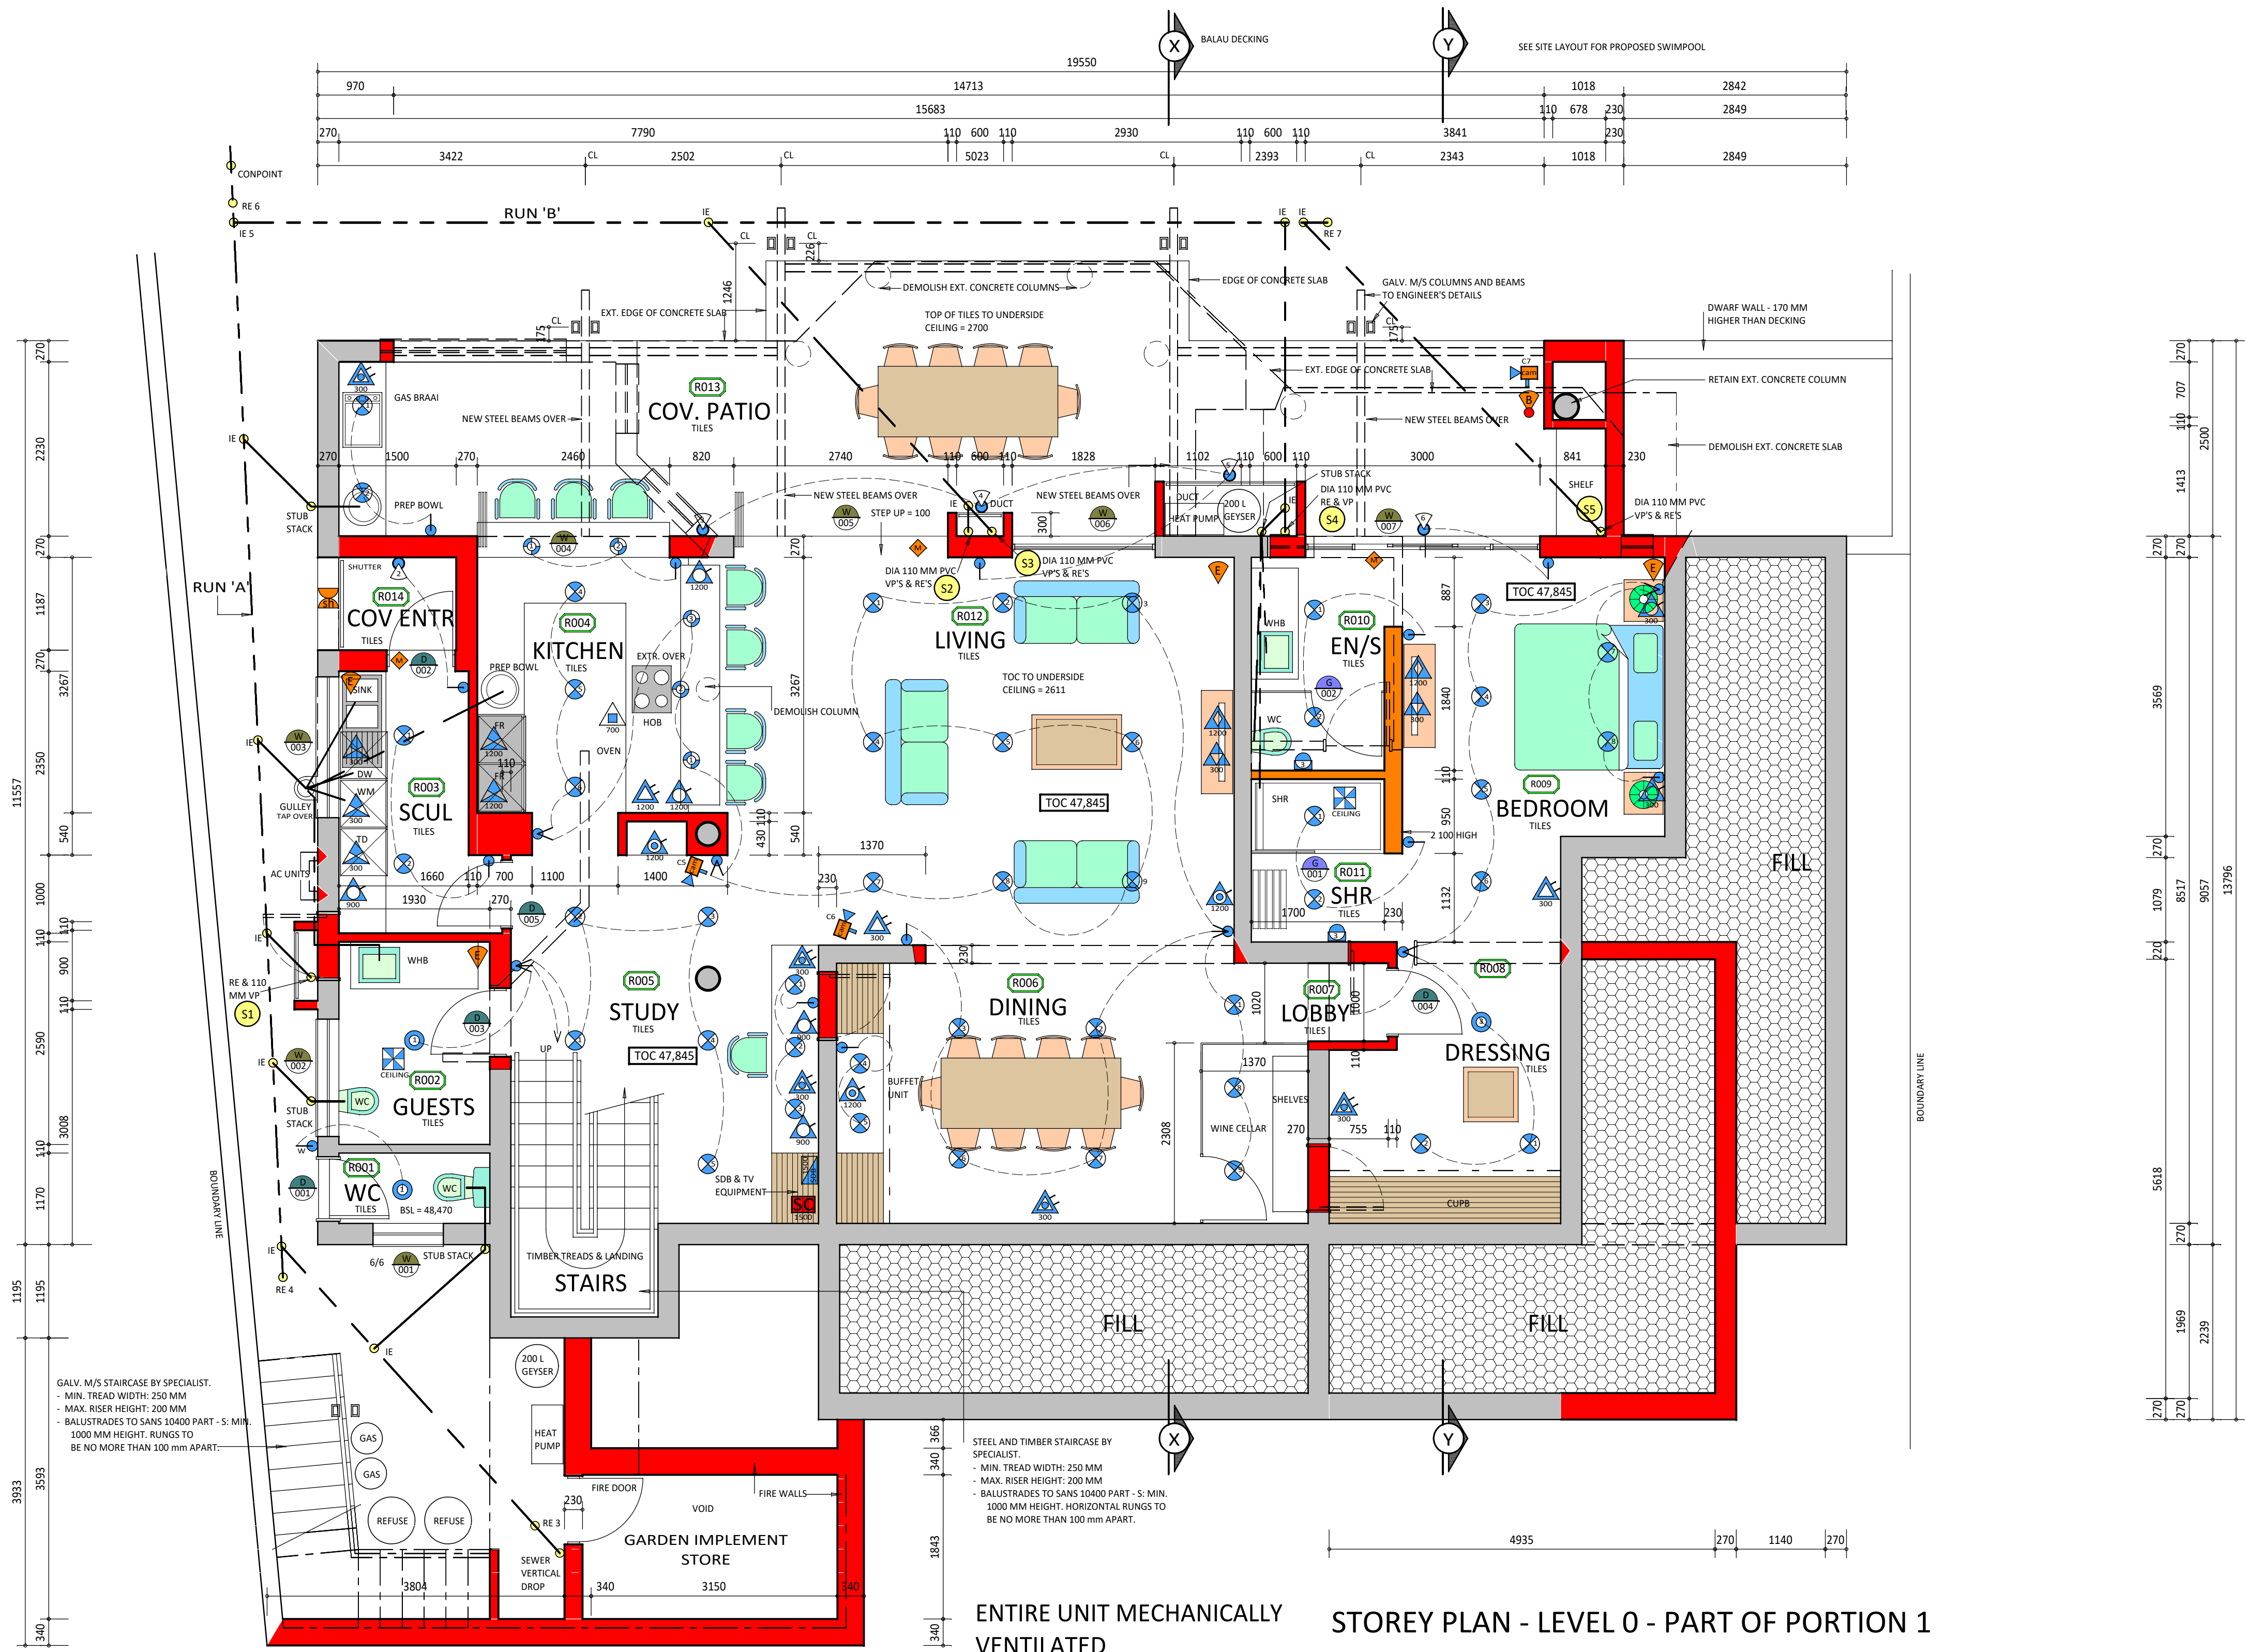

ENTIRE UNIT MECHANICALLY VENTILATED

STOREY PLAN - LEVEL 0 - PART OF PORTION 1

ELECTRICAL - LIGHTS	
	INTERNAL FOOT LIGHT
	2 WATT LED F/L
	EXTERNAL FOOT LIGHT (LED)
	2 WATT LED D/L
	RECESSED CEILING DOWNLIGHT
	5 WATT LED D/L
	12 WATT LED D/L
	16 WATT LED D/L
	WALL LIGHT
	20 WATT LED W/L
	EMERGENCY FLOODLIGHT (LED)
	MOTION DETECTION & DAY/NIGHT
	EXTERNAL WALL LIGHT (LED)
	MOTION DETECTION & DAY/NIGHT
	CABINET LIGHTS
	2 WATT LED
	LED PENDANT
	1,200 MM DOUBLE TUBE
	16 WATT FLUORESCENT STRIP LIGHTS (LED)

ELECTRICAL - PLUGS	
	16A COMBINATION SWITCH SOCKET PRE-WIRED 1 X RSA SWITCHED PLUS 2 EURO SOCKET PLUS 1 X 40B 4 X 4 INCH
	16A DOUBLE SWITCHED SOCKET OUTLET 4 X 4 INCH
	16A COMBINATION SWITCH SOCKET PRE-WIRED 1 X RSA SWITCHED PLUS 1 EURO SOCKET PLUS 1 X SCHUKO 4 X 4 INCH
	16A COMBINATION SWITCH SOCKET PRE-WIRED 1 X RSA SWITCHED PLUS 3 X EURO SOCKET DEDICATED SOCKETS 4 X 4 INCH
	16A SWITCHED SOCKET OUTLET 4 X 4 INCH
	HEATED TOWEL RAIL ON TIMER
	TELEPHONE SOCKET
	STOVE CONNECTION HEIGHT INDICATED BELOW SYMBOL
	GANGBOX - HEIGHT BELOW SYMBOL 3P = 1 X SA THREE PRONG PLUG 5 = 1 X 'SHUKO' PLUG E = 3 X EUROPLUS

ELECTRICAL - GENERAL	
	LIGHT SWITCH POINT 750 MM ABOVE FFL 'D' MEANS BELL PUSH BUTTON DIMMER
	WATER TIGHT LIGHT SWITCH POINT
	LIGHT SWITCH POINT
	EMERGENCY FLOOD LIGHT
	'MD' MEANS ON MOTION DETECTOR
	'D/N' MEANS DAY/NIGHT DETECTION
	'D' MEANS DIMMER LIGHT SWITCH
	'2' WITH LIGHT SWITCHES MEANS 2 WAY SUB-DISTRIBUTION BOARD 1500 MM ABOVE FFL
	UFH THERMOSTAT 300 MM ABOVE FFL
	SMOKE DETECTION CONTROL BOX 1500 MM ABOVE FFL
	CEILING MOUNTED SMOKE DETECTOR
	CEILING FAN

REVISIONS	
SYMBOL	DESCRIPTION
	.
	.
CONTRACTOR & GEN. NOTES	
● ALL MATERIALS ETC. TO BE FITTED IN STRICT ACCORDANCE WITH MANUFACTURERS' SPECIFICATIONS.	
● ALL SPECIFICATIONS ETC. TO BE IN ACCORDANCE WITH MODEL PREAMBLES FOR TRADES AS PUBLISHED BY THE ASSOCIATION OF SOUTH-AFRICAN QUANTITY SURVEYORS.	
● ALL WORK TO BE DONE IN ACCORDANCE WITH THE NATIONAL BUILDING REGULATIONS (SOUTH AFRICAN CODE OF PRACTICE) AND BUILDING STANDARDS ACT, ACT SABS 0400-1990.	
● CONTRACTOR TO ALLOW FOR ARCHITECTS BOARD	
● ALL ELECTRICAL WIRES IN WALLS, FLOORS AND CEILINGS TO RUN IN SABS APPROVED CONDUITS	
● REGULATIONS AND REQUIREMENTS OF ALL RELEVANT AUTHORITIES TO BE ADHERED TO.	
● CONTRACTORS TO CHECK ALL DIMENSIONS AND LEVELS ON SITE BEFORE COMMENCING WITH WORK.	
● FIGURED DIMENSIONS TO BE TAKEN IN PREFERENCE TO SCALED MEASUREMENTS.	
● ALL STRUCTURAL DESIGN TO BE THE RESPONSIBILITY OF A PROFESSIONAL ENGINEER.	
● COPYRIGHT RESERVED.	



Physical address

59 A CHURCH ROAD
WALMER, 6070
PORT ELIZABETH

Postal address

PO BOX 5205
WALMER, 6065
PORT ELIZABETH

Postal address

tel no. +27 (0) 41 581-1110
fax no. +27 (0) 41 581-0559
cell no. 082 65 92 964
e-mail. info@ev-architects.co.za
web. www.ev-architects.co.za

ERIK VOIGT ARCHITECTS	
OWNER	
HQA OR BC	NOT APPLICABLE

AWAITING	

ALARM MODULES	
APARTMENT NO. 1	LOWER GROUND STOREY - LEVEL 0 - ZONE 3
RM	RM NAME NO OF CONTROL WHERE
R001	LOUNGE 1 DOOR MAGNET STACKER
R002	LOUNGE 1 SENSOR ROOM
R003	GUEST BEDROOM 1 DOOR MAGNET SLIDER
R004	GUEST BEDROOM 1 SENSOR ROOM
R005	SCULLERY 1 DOOR MAGNET BACK DOOR
R006	SCULLERY 1 SENSOR ROOM
R007	YARD 1 BEAM COVERED PATIO 1 BEAM

ELECTRICAL NUMBERING	
APARTMENT NO. 1	LOWER GR. STOREY - LEVEL 0
RM	RM NAME FITT NO. CONTROL NO OF TYPE
R001	LOUNGE 1-9 SWITCH/DIMMER 9 SW LED D/L
R002	LOUNGE 1 SWITCH 1 SW LED D/L
R003	DINING 1-8 SWITCH/DIMMER 8 SW LED D/L
R004	DINING 10-11 SWITCH 2 SW LED D/L
R005	GUEST BEDRM 1-2 SWITCH 2 SW LED D/L
R006	GUEST BEDRM 3-6 SWITCH 4 SW LED D/L
R007	DRESSING 1-2 SWITCH/DIMMER 2 SW LED D/L
R008	DRESSING 3 SWITCH/DIMMER 1 16W LED D/L
R009	GUEST EN SUITE 1-2 SWITCH 2 SW LED D/L
R010	GUEST EN SUITE 3 MOVE/DN 1 2W LED F/L
R011	SHOWER 1-2 SWITCH 2 SW LED D/L
R012	SHOWER 3 MOVE/DN 1 2W LED F/L
R013	KITCHEN 1-3 SWITCH 3 LED PENDANT
R014	KITCHEN 4-6 SWITCH/DIMMER 3 SW LED F/L
R015	SCULLERY 1-2 SWITCH/DIMMER 2 SW LED D/L
R016	SCULLERY 3 SWITCH 1 20W LED W/L
R017	YARD 1-2 SWITCH 2 20W LED W/L
R018	GUEST TOILET 1 SWITCH 1 16W LED D/L
R019	STUDY 1-3 SWITCH 3 SW LED D/L
R020	STUDY 4-6 SWITCH 2 SW LED D/L
R021	COVERED PATIO 1-2 SWITCH 2 SW LED D/L
R022	COVERED PATIO 3-4 SWITCH 2 20W LED W/L
R023	OUTSIDE TOILET 1 SWITCH 1 16W LED D/L

SYMBOL LEGEND	
	INDICATES DEMOLITIONS - ON SITE PLAN
	INDICATES EXISTING WALLS
	INDICATES CLAY BRICK WALLS
	INDICATES CONCRETE STRUCTURE
	INDICATES TOP OF CONCRETE
	INDICATES ROOM NUMBERS
	INDICATES DOOR NUMBERS
	INDICATES WINDOW NUMBERS
	INDICATES GLAZED PARTITION NUMBERS

SECURITY LEGEND	
	ALARM CONTROL BOX 2000 MM ABOVE FFL
	ALARM KEYPAD 1250 MM ABOVE FFL
	VIDEO CAMERA
	INTERCOM 1250 MM ABOVE FFL
	MAGNET
	SECURITY EYE
	BIOMETRIC READER
	SECURITY BEAM
	SHUTTER O/C

PROJECT, TITLES & DATA	
Project	
PROPOSED ALTS & ADDS FOR 'NANOMIX' ON ERF 2331 SUMMERSTRAND	
Drawing title	
STOREY PLANS LOWER GROUND STOREY - LEVEL 0	
Index data	
Job No.	5020-01
Drwg. No.	02(WU)
Rev. No.	R21
Scale	1 : 50
Date	MAR 2021
Drawn	ERIK VOIGT
SACAP 4182	SAIA PV1748